


STAGE LIGHTING PLOT

THE HISTORIC EVERETT THEATRE
2911 COLBY AVE, EVERETT WA

PREPARED BY LIGHTING SOLUTIONS NW
15716 15th AVE NE # 308
Seattle, WA
206-660-3753

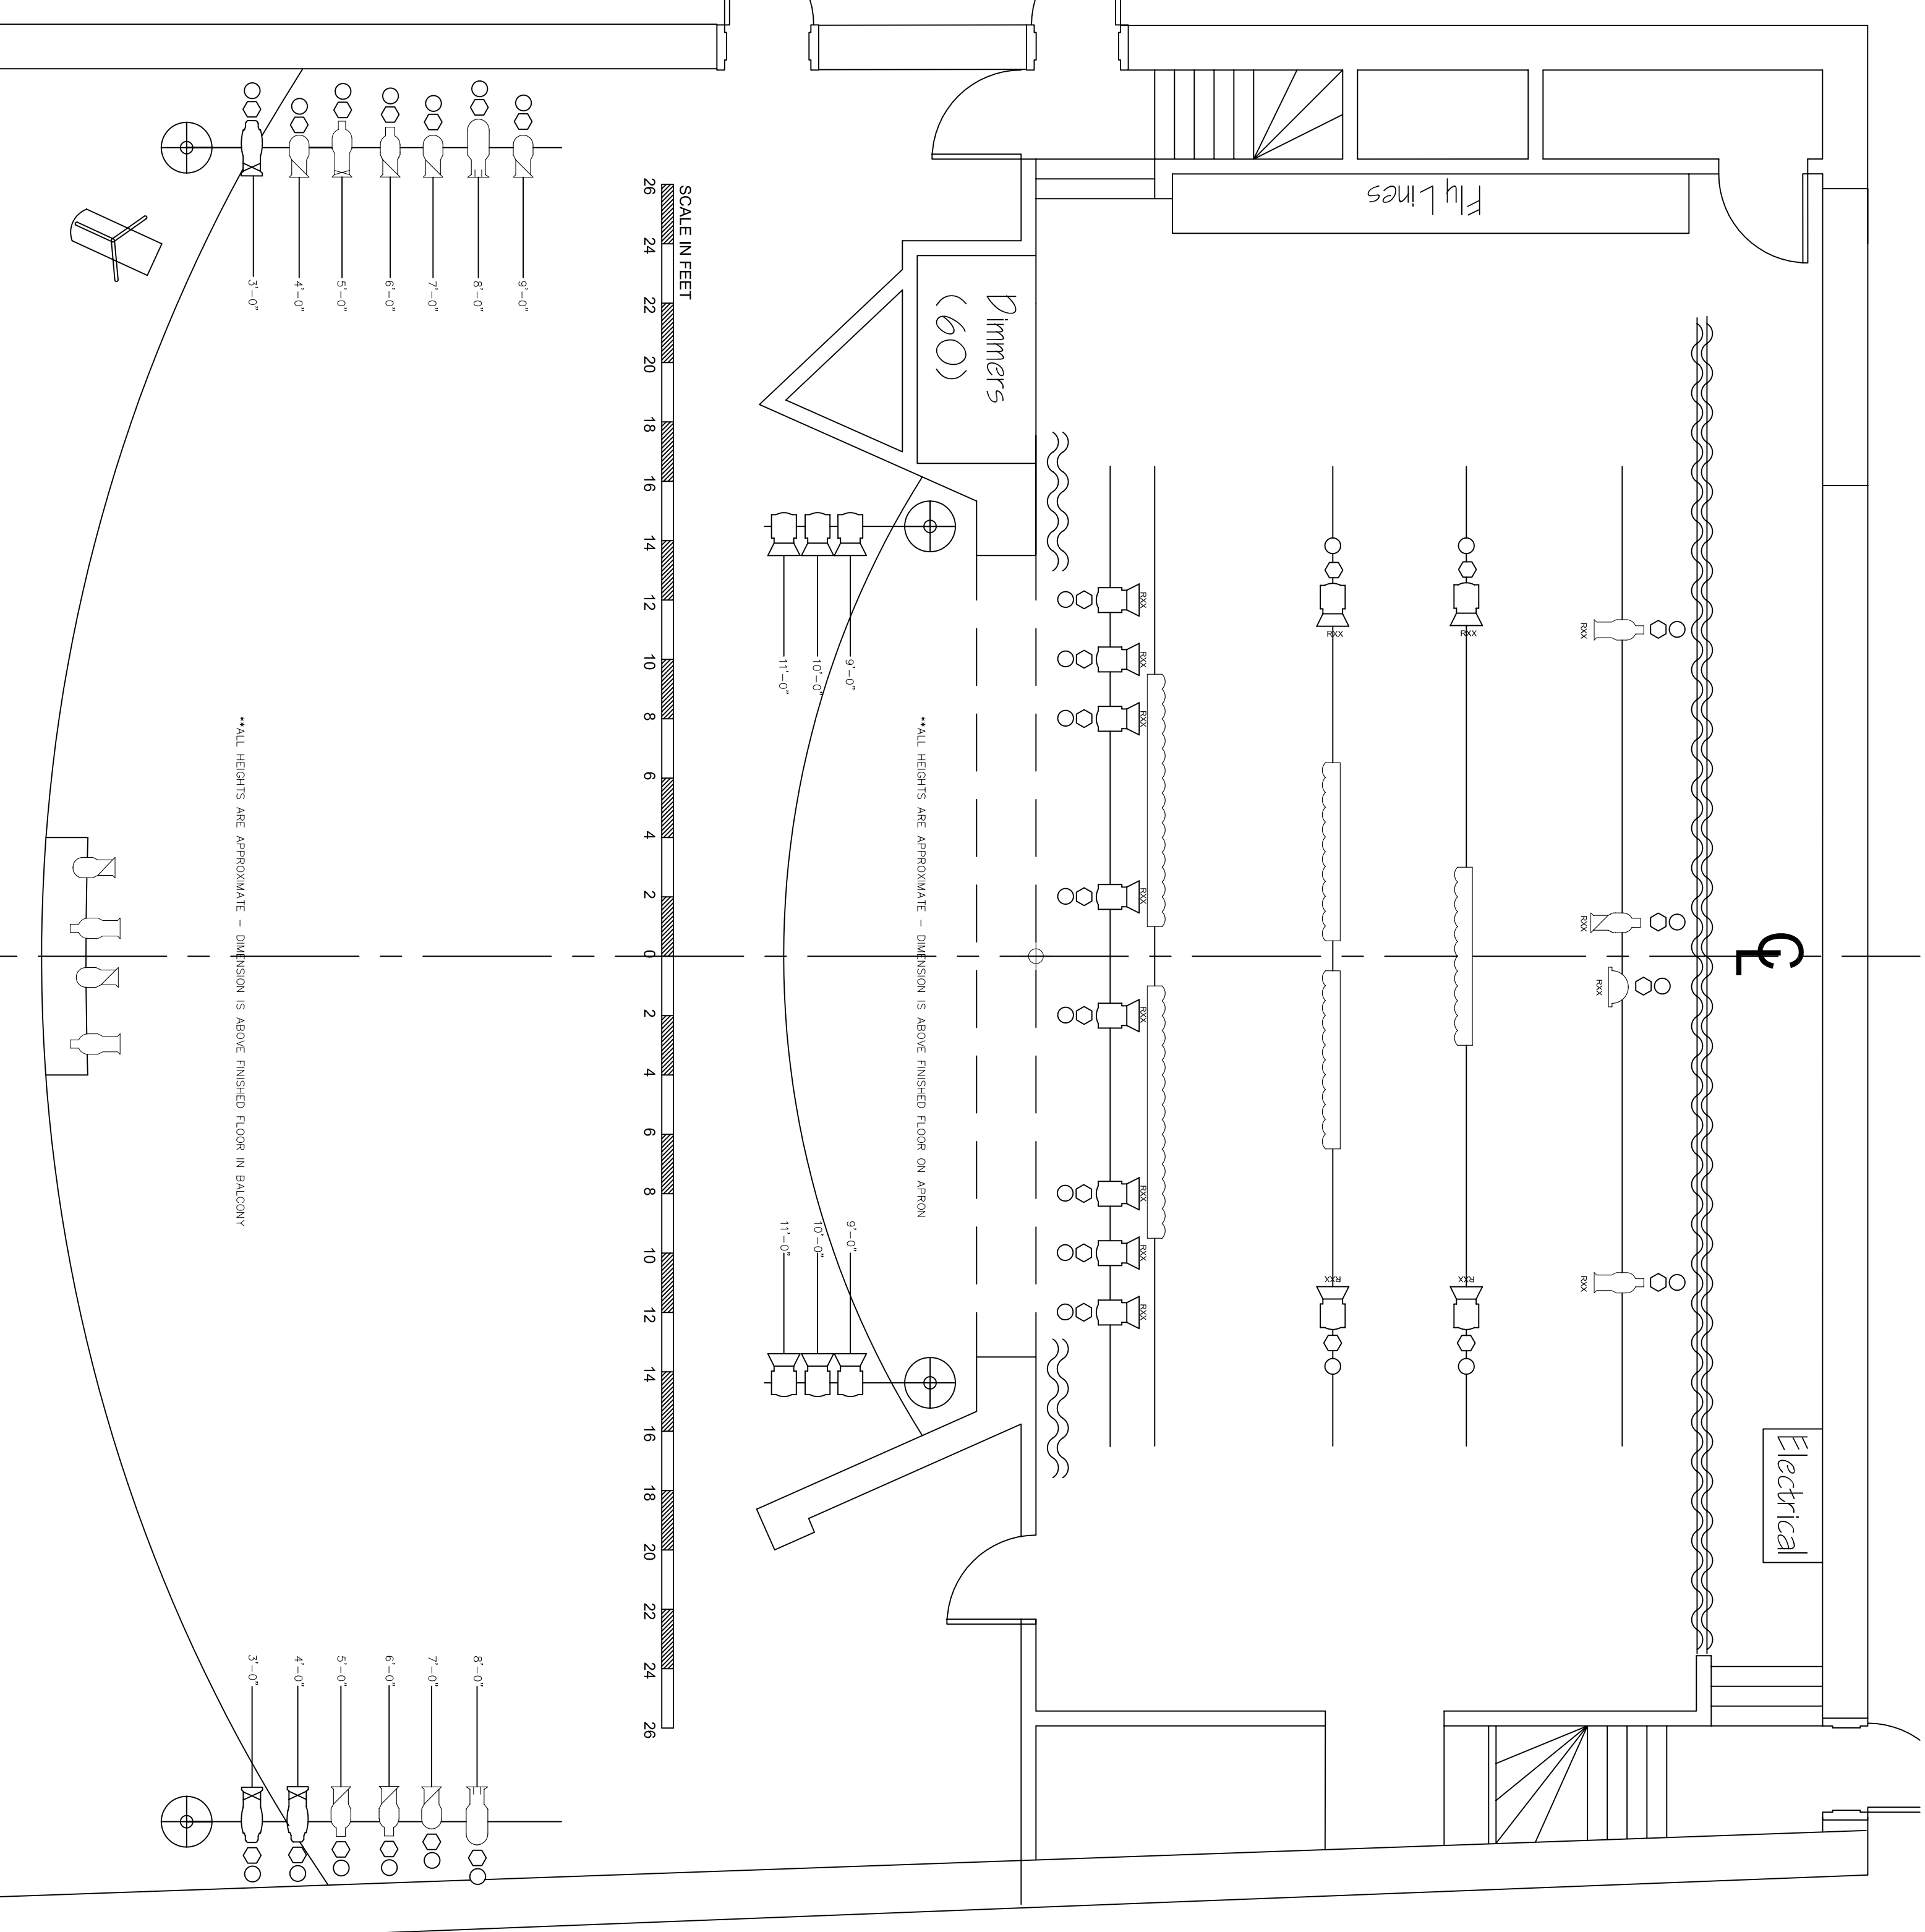

1 STAGE LIGHTING PLAN
Scale: 1/4" = 1'-0"

ELEVATION	PLAN SYMBOL	DESCRIPTION	QTY.
		ETC SOURCE 4 19" ELLIPSOIDAL SPOTLIGHT	3
		ALTMAN 3800 6 x 16 ELLIPSOIDAL SPOTLIGHT	1
		STRAND TLEKO 6 x 12 ELLIPSOIDAL SPOTLIGHT	6
		ALTMAN 3800 6 x 12 ELLIPSOIDAL SPOTLIGHT	4
		ALTMAN 3800 6 x 9 ELLIPSOIDAL SPOTLIGHT	4
		STRAND TLEKO 8 x 13 ELLIPSOIDAL SPOTLIGHT	2
		ALTMAN 650 6" FRESNEL	18
		ALTMAN 16" SCOOP	1
		6 12 LAMP BORDERLIGHT	3
		8 16 LAMP BORDERLIGHT	2
		LYOAN SUPERARC 350 FOLLOWSPOT	1
		FOCUS COLOR BEAM SPREAD	
		DIMMER/CIRCUIT CHANNEL	

2 STAGE LIGHTING KEY
Scale: NTS